

4

3

2

1

DO NOT SCALE

BILL OF MATERIAL

NO. TO SHIP	SHIP MARK	NO. PCS.	PC. MK.	SECTION	LENGTH		REMARKS
					FT.	IN.	


D

C

B

A

a
b
c
d
f
h
k
m
n
p
s
t
v
w
aa
ab
ac
ad
af
ah
ak
am
an
ap
as
at
av
aw

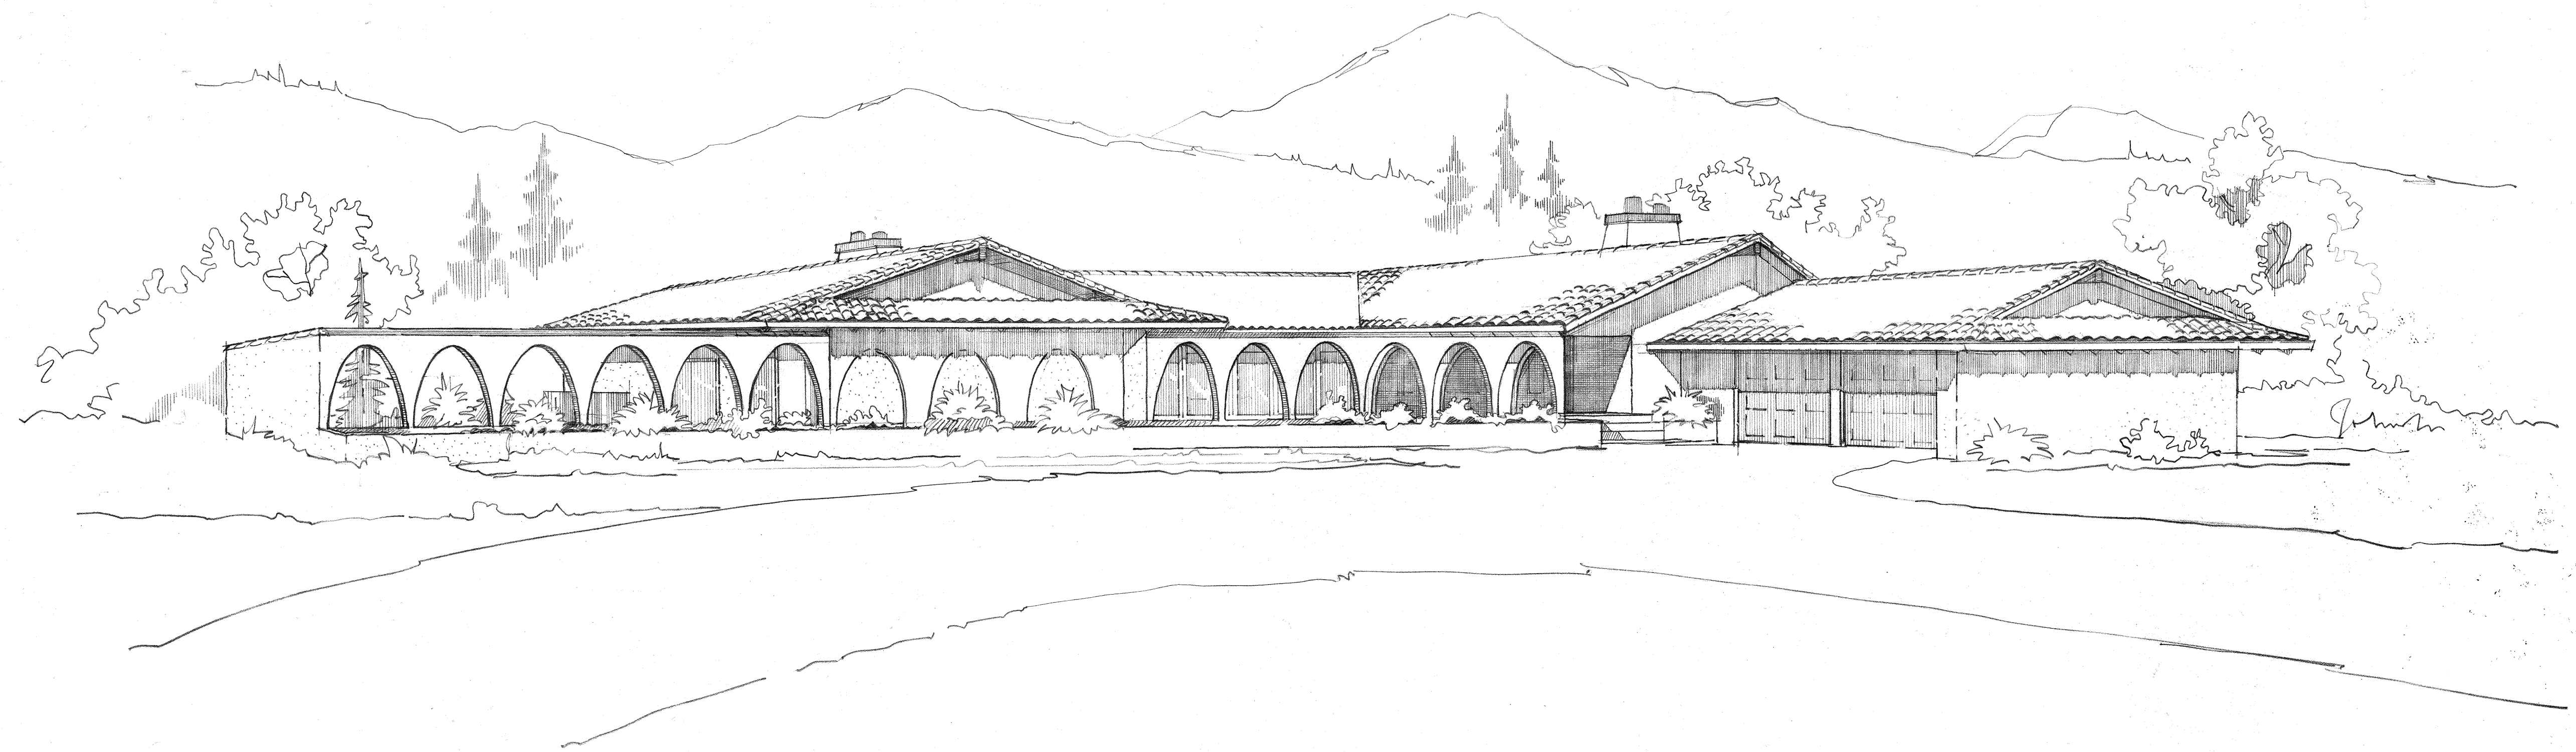

PERSPECTIVE

ITEM NO.	QTY	PART NO.	MATERIAL	DRAWING NUMBER	DESCRIPTION
					Diversified Design Inc. PROFESSIONAL ENGINEERS & DESIGNERS P. O. BOX 1081 EVERETT, WASHINGTON 98201
					PROJECT:
					CUSTOMER:
					DATE: REVISION: APP'D:
					DRAWN BY: <u>MILL.</u> SCALE: <u>NONE</u> DATE: <u>4-16-75</u>
					TRACED BY: CHECKED BY: APPROVED:
					ORDER NO. CODE: <u>R.O.</u> DRWG. NO. <u>D-10E11</u> REV.:

4

3

2

1

4

3


2

1


DO NOT SCALE

BILL OF MATERIAL


NO. TO SHIP	SHIP MARK	NO. PCS.	PC. MK.	SECTION	LENGTH		REMARKS
					FT.	IN.	

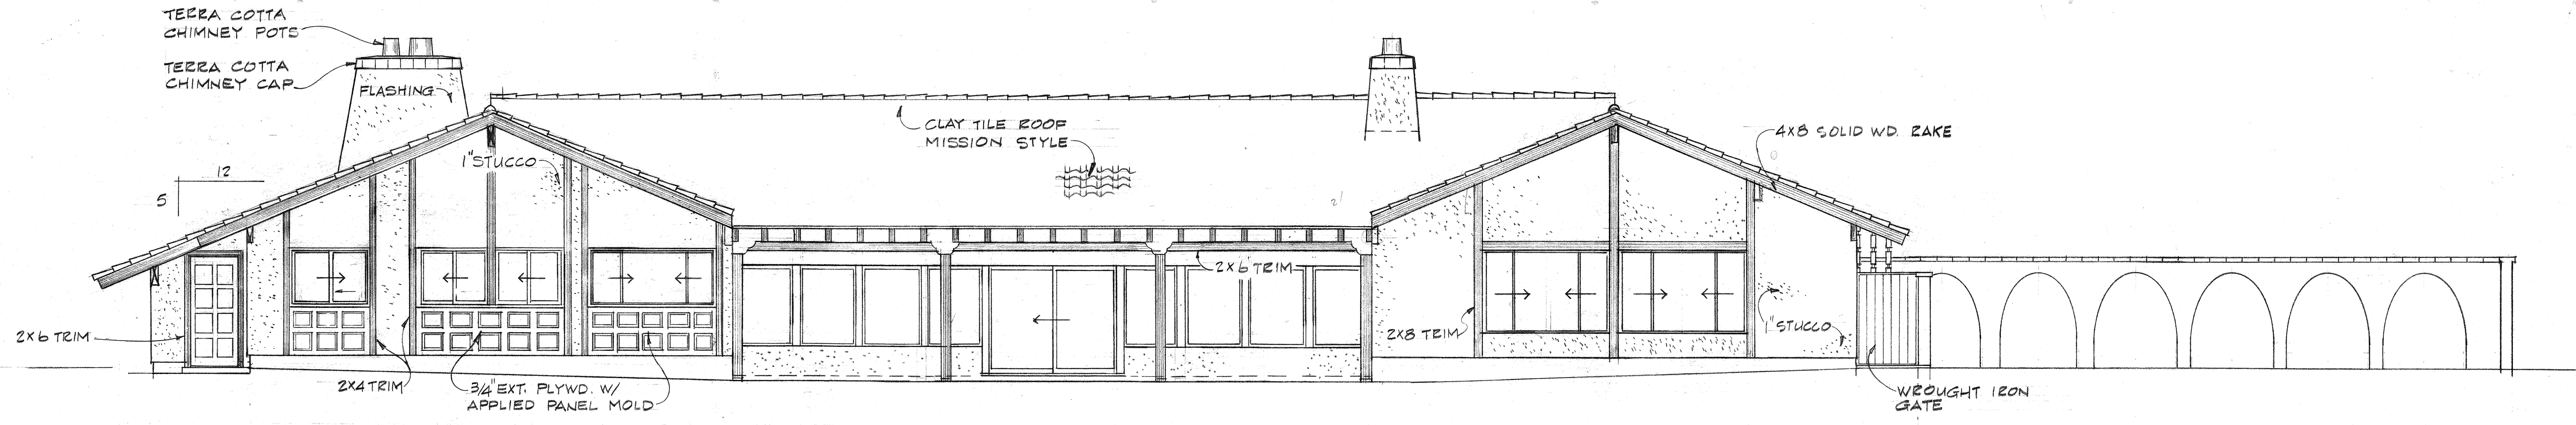


REAR ELEVATION

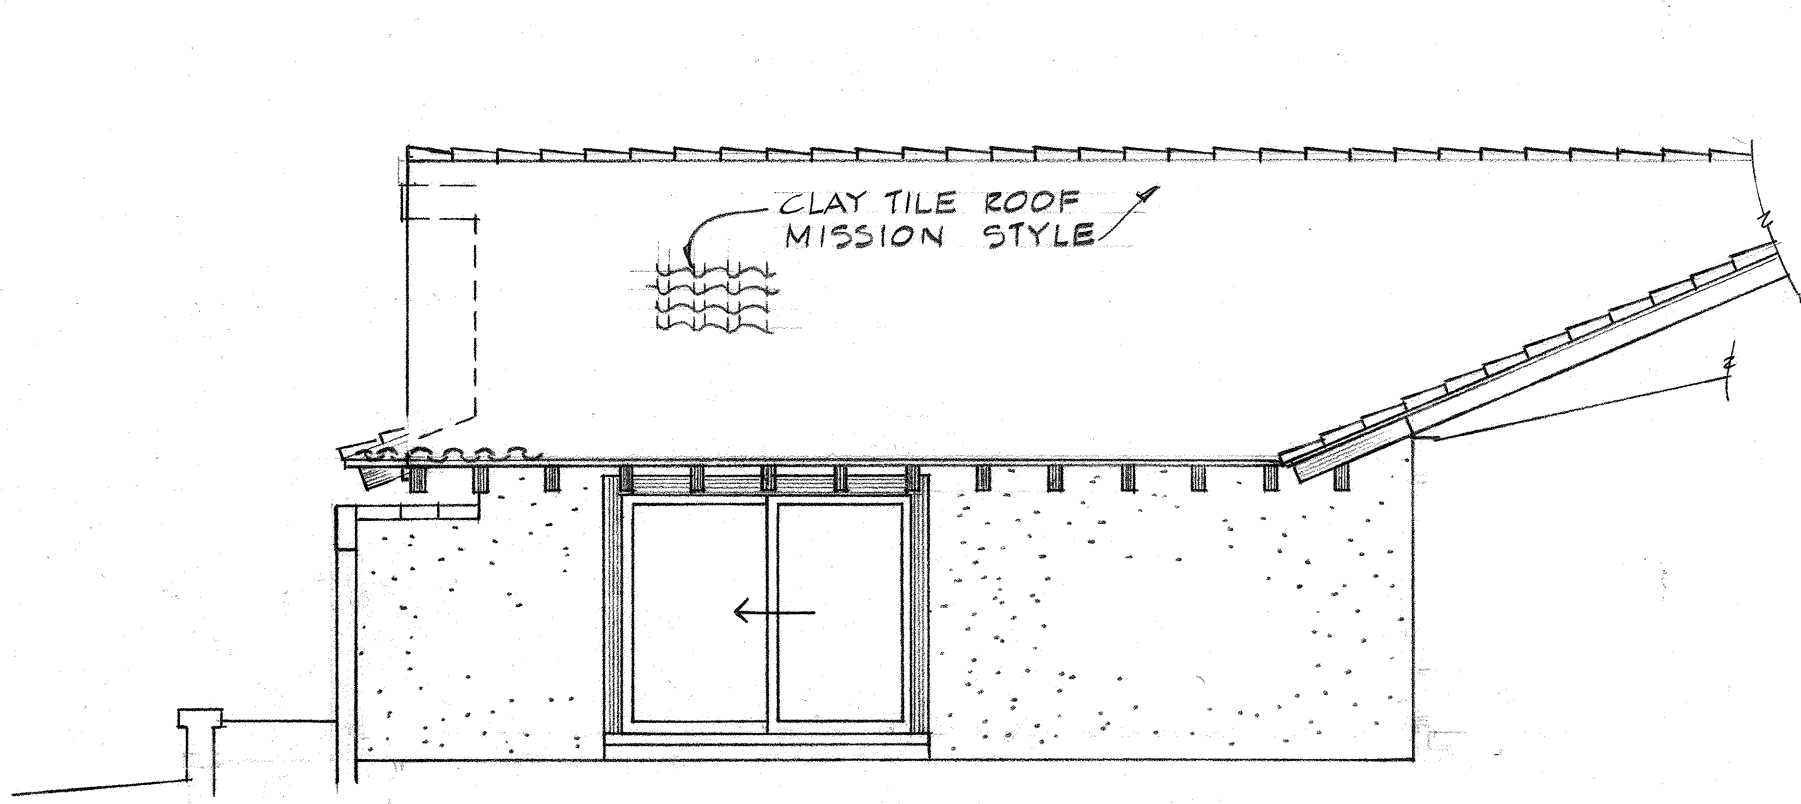

LEFT SIDE COURT ELEVATION

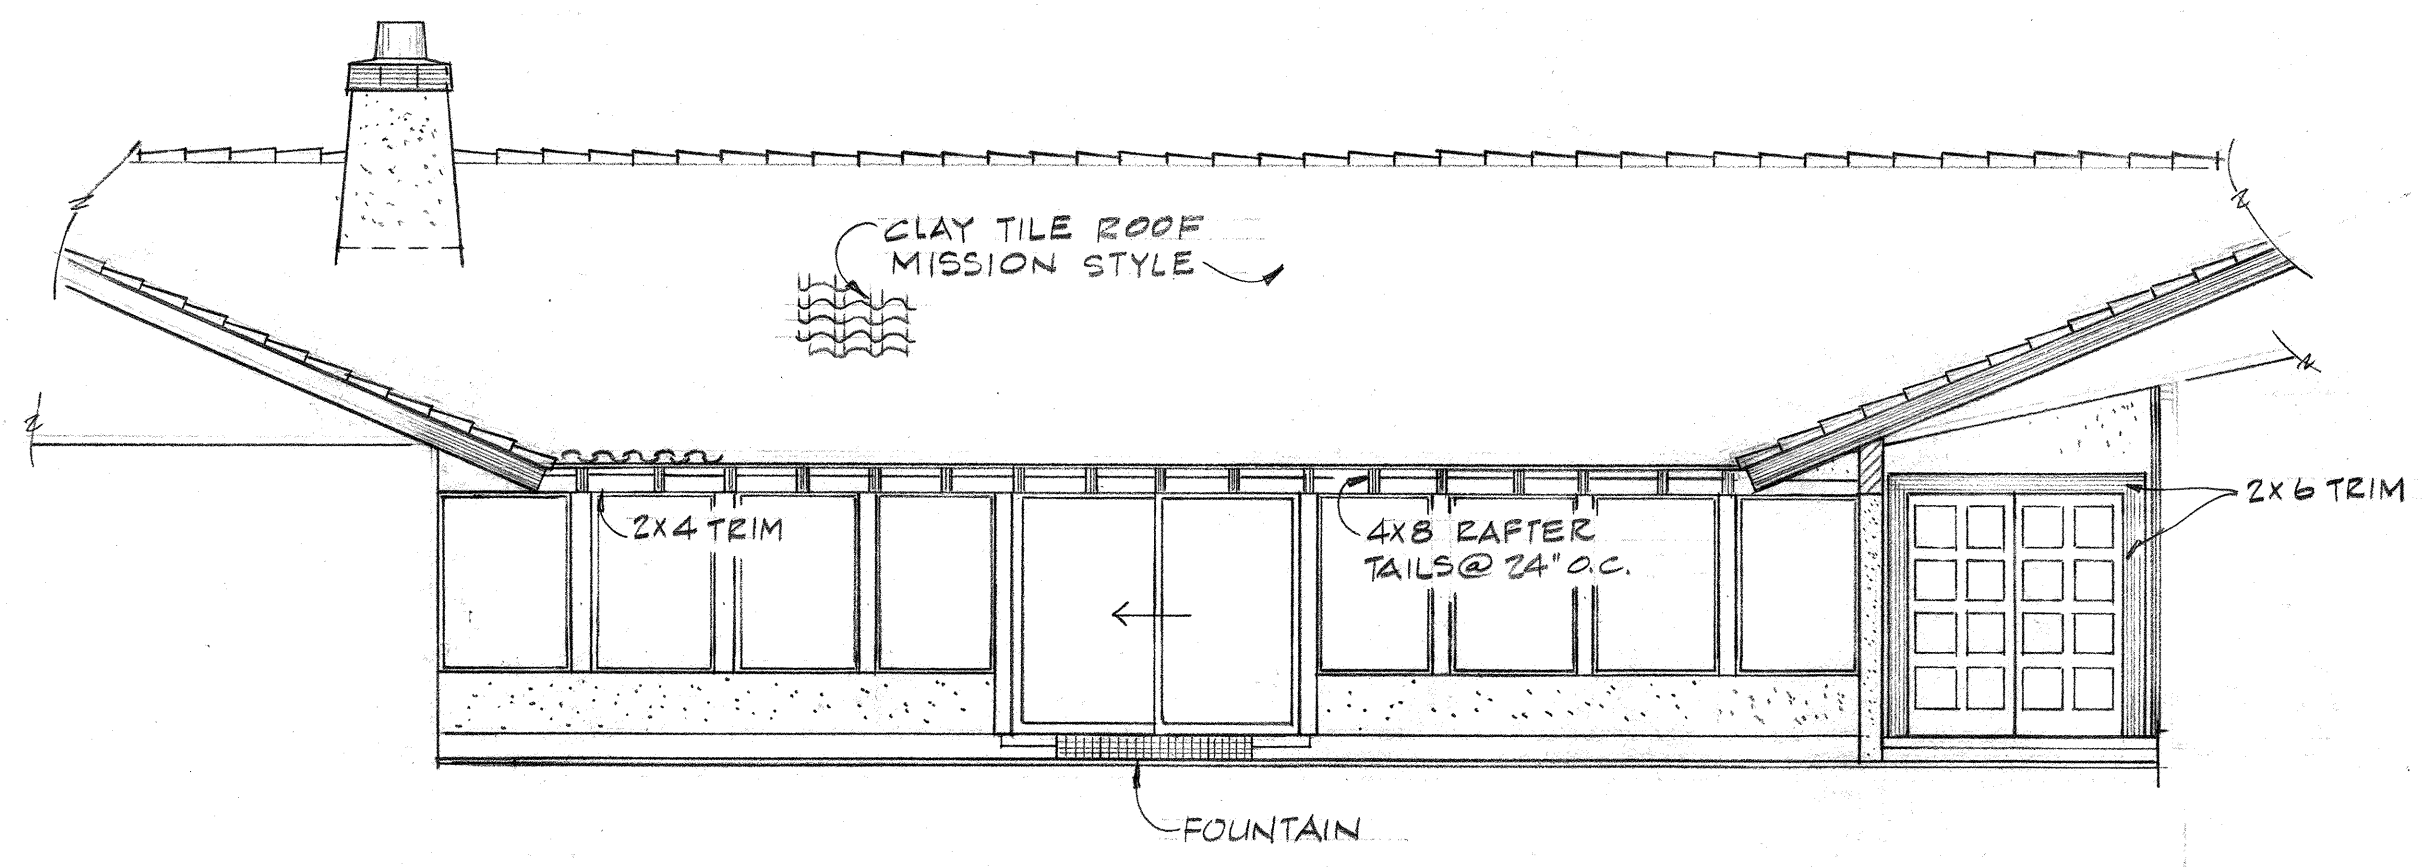

HOUSE COURT ELEVATION

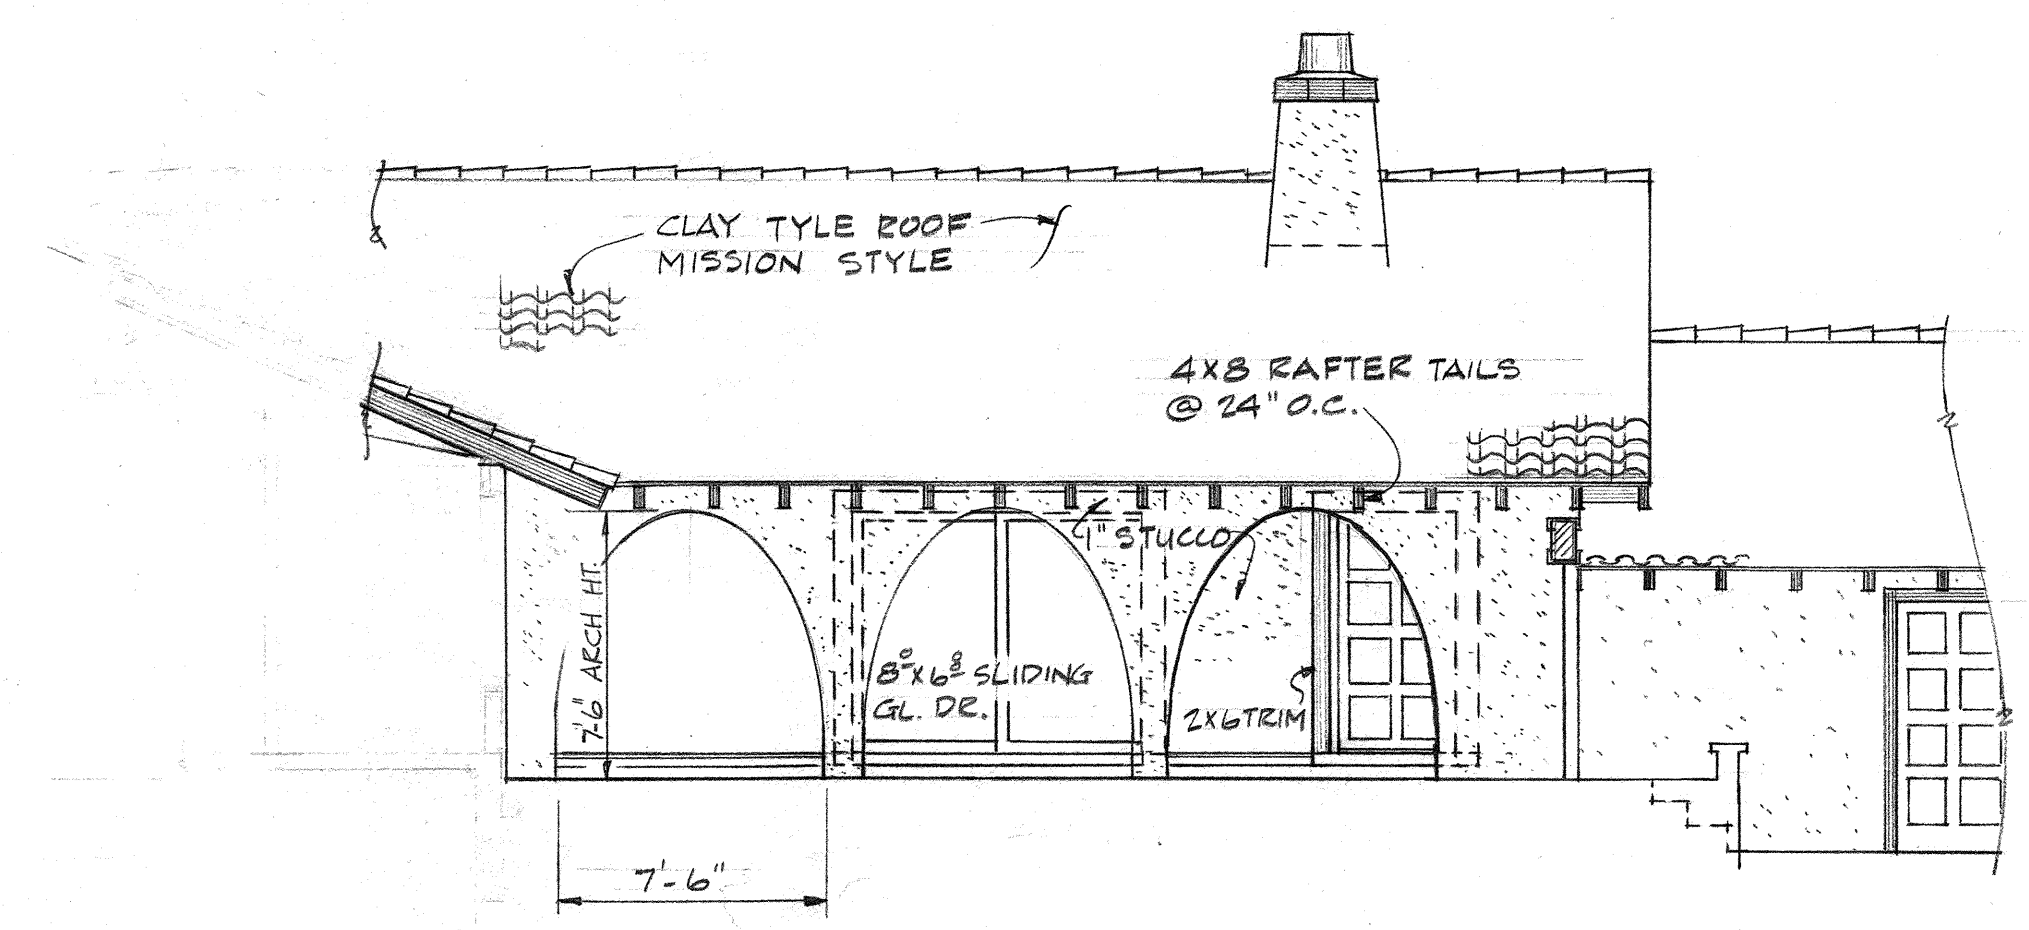

RIGHT SIDE ELEVATION

ELEVATIONS

ITEM NO.	QTY	PART NO.	MATERIAL	DRAWING NUMBER	DESCRIPTION
Diversified Design Inc. PROFESSIONAL ENGINEERS & DESIGNERS P. O. BOX 1081 EVERETT, WASHINGTON 98201					
PROJECT:					
CUSTOMER:					
DATE	REVISION	APP'D	DRAWN BY SUE SCALE 3/8"=1'-0" DATE 3-6-75		
TRACED BY			CHECKED BY	APPROVED	
ORDER NO.	CODE	DRWG. NO.	REV.	RD D-5 OF 11	

4

3

2

1

D

C

B

A

a
b
c
d
f
h
k
m
n
p
s
t
v
w
aa
ab
ac
ad
af
ah
ak
am
an
ap
as
at
av
aw

4

3


2

1


DO NOT SCALE

BILL OF MATERIAL


NO. TO SHIP	SHIP MARK	NO. PCS.	PC. MK.	SECTION	LENGTH		REMARKS
					FT.	IN.	

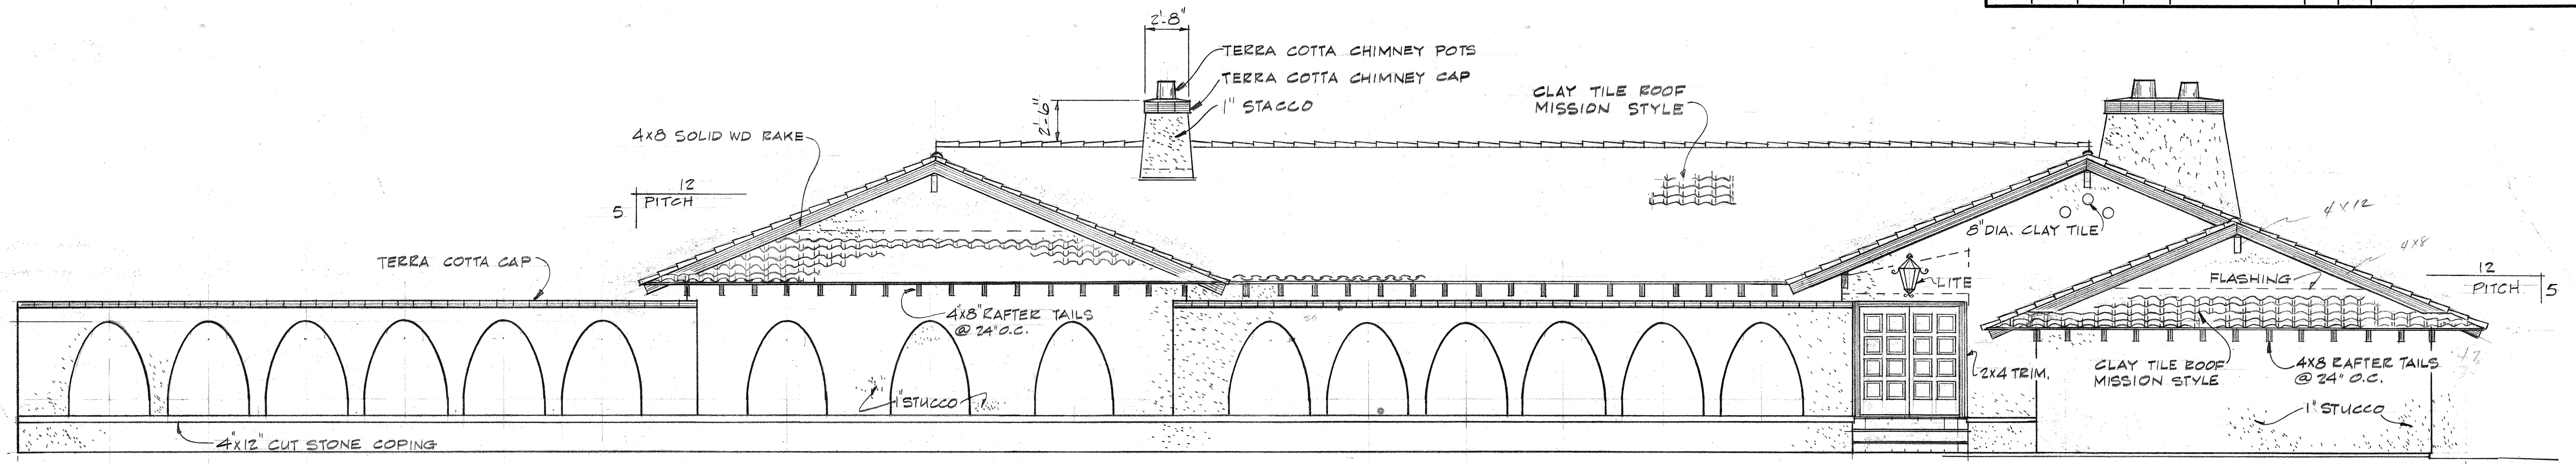

FRONT ELEVATION

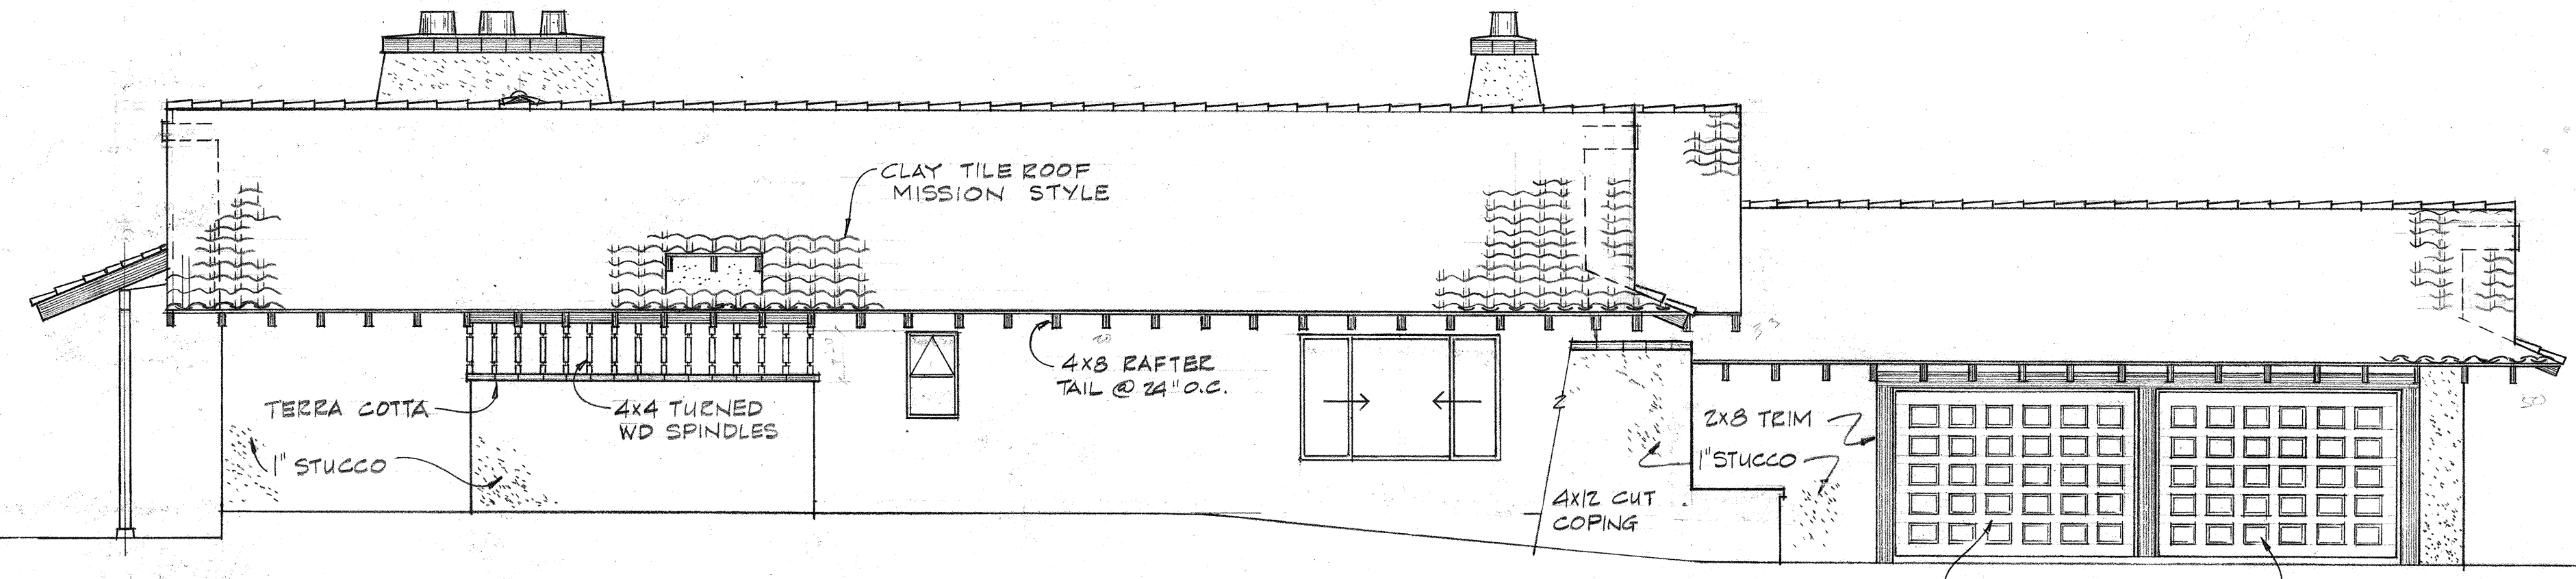

LEFT SIDE ELEVATION

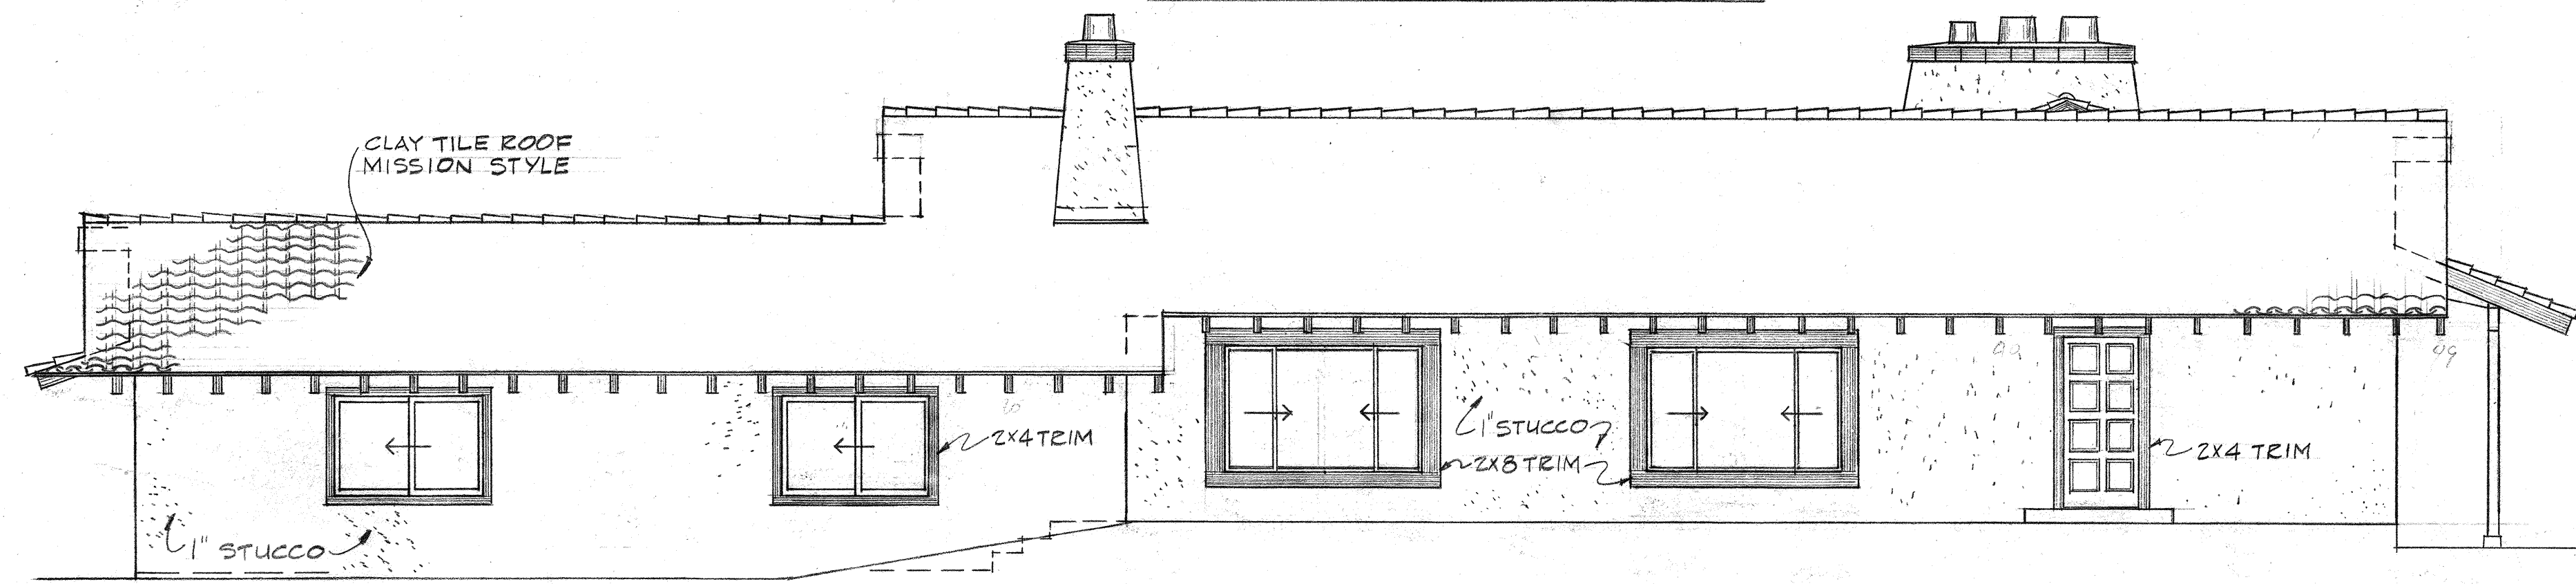

RIGHT SIDE ELEVATION

ELEVATIONS

ITEM NO.	QTY	PART NO.	MATERIAL	DRAWING NUMBER	DESCRIPTION
Diversified Design Inc. PROFESSIONAL ENGINEERS & DESIGNERS P. O. BOX 1081 EVERETT, WASHINGTON 98201					
PROJECT:					
CUSTOMER:					
DATE	REVISION	APP'D	DRAWN BY SUE		
			SCALE 3/16" = 1'-0"	DATE 3-25-75	
			TRACED BY	CHECKED BY	APPROVED
			ORDER NO.	CODE	DRWG. NO.
				R.D	D-4 OF 11

4

3

2

1

D

C

B

A

a
b
c
d
e
f
g
h
i
j
k
l
m
n
o
p
q
r
s
t
u
v
w
x
y
z
aa
ab
ac
ad
ae
af
ag
ah
ai
aj
ak
al
am
an
ao
ap
aq
ar
as
at
au
av
aw

4

3

2

1



DO NOT SCALE

BILL OF MATERIAL

NO. TO SHIP	SHIP MARK	NO. PCS.	PC. MK.	SECTION	LENGTH		REMARKS
					FT.	IN.	

ROOF AREA TOTAL 7773 SQ FT

GABLE ENDS 184 LIN FT

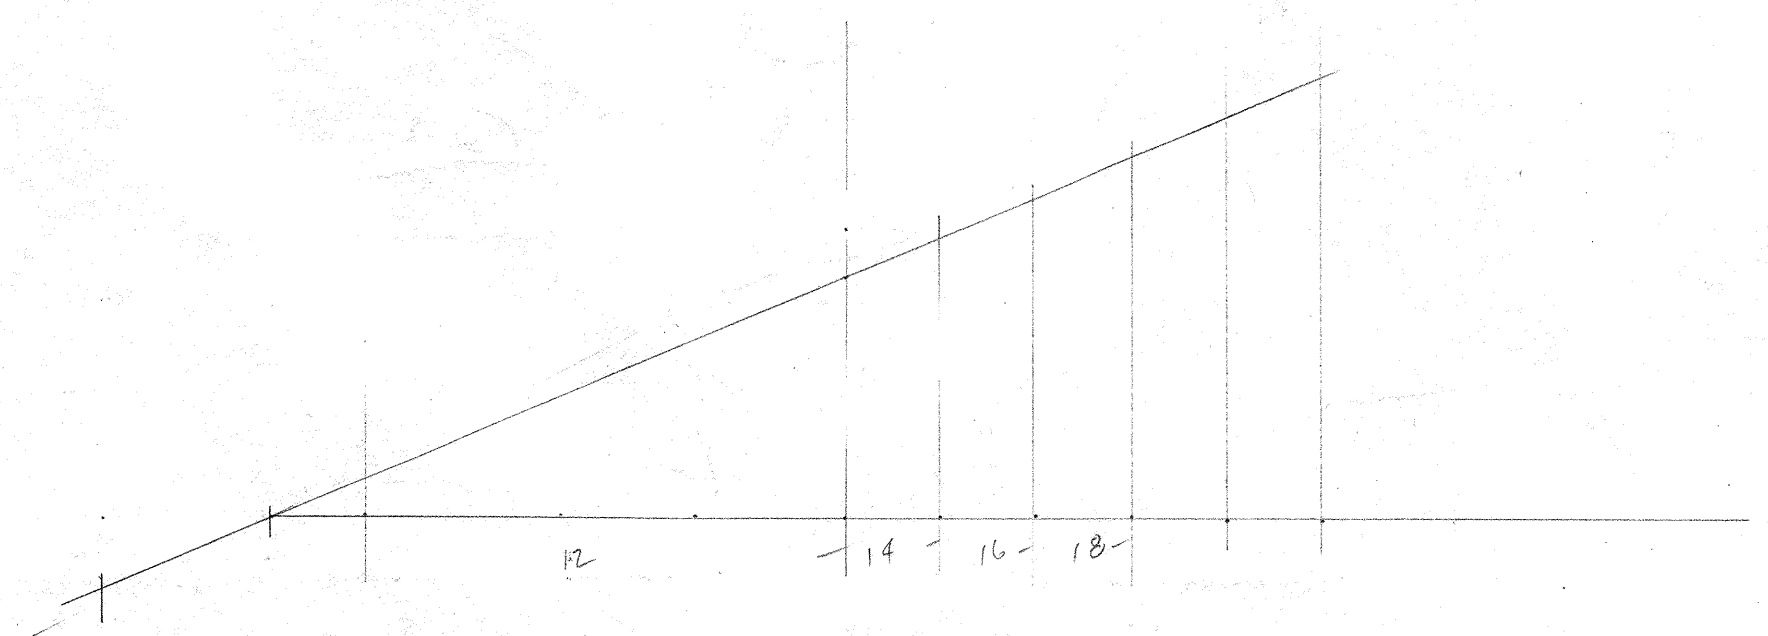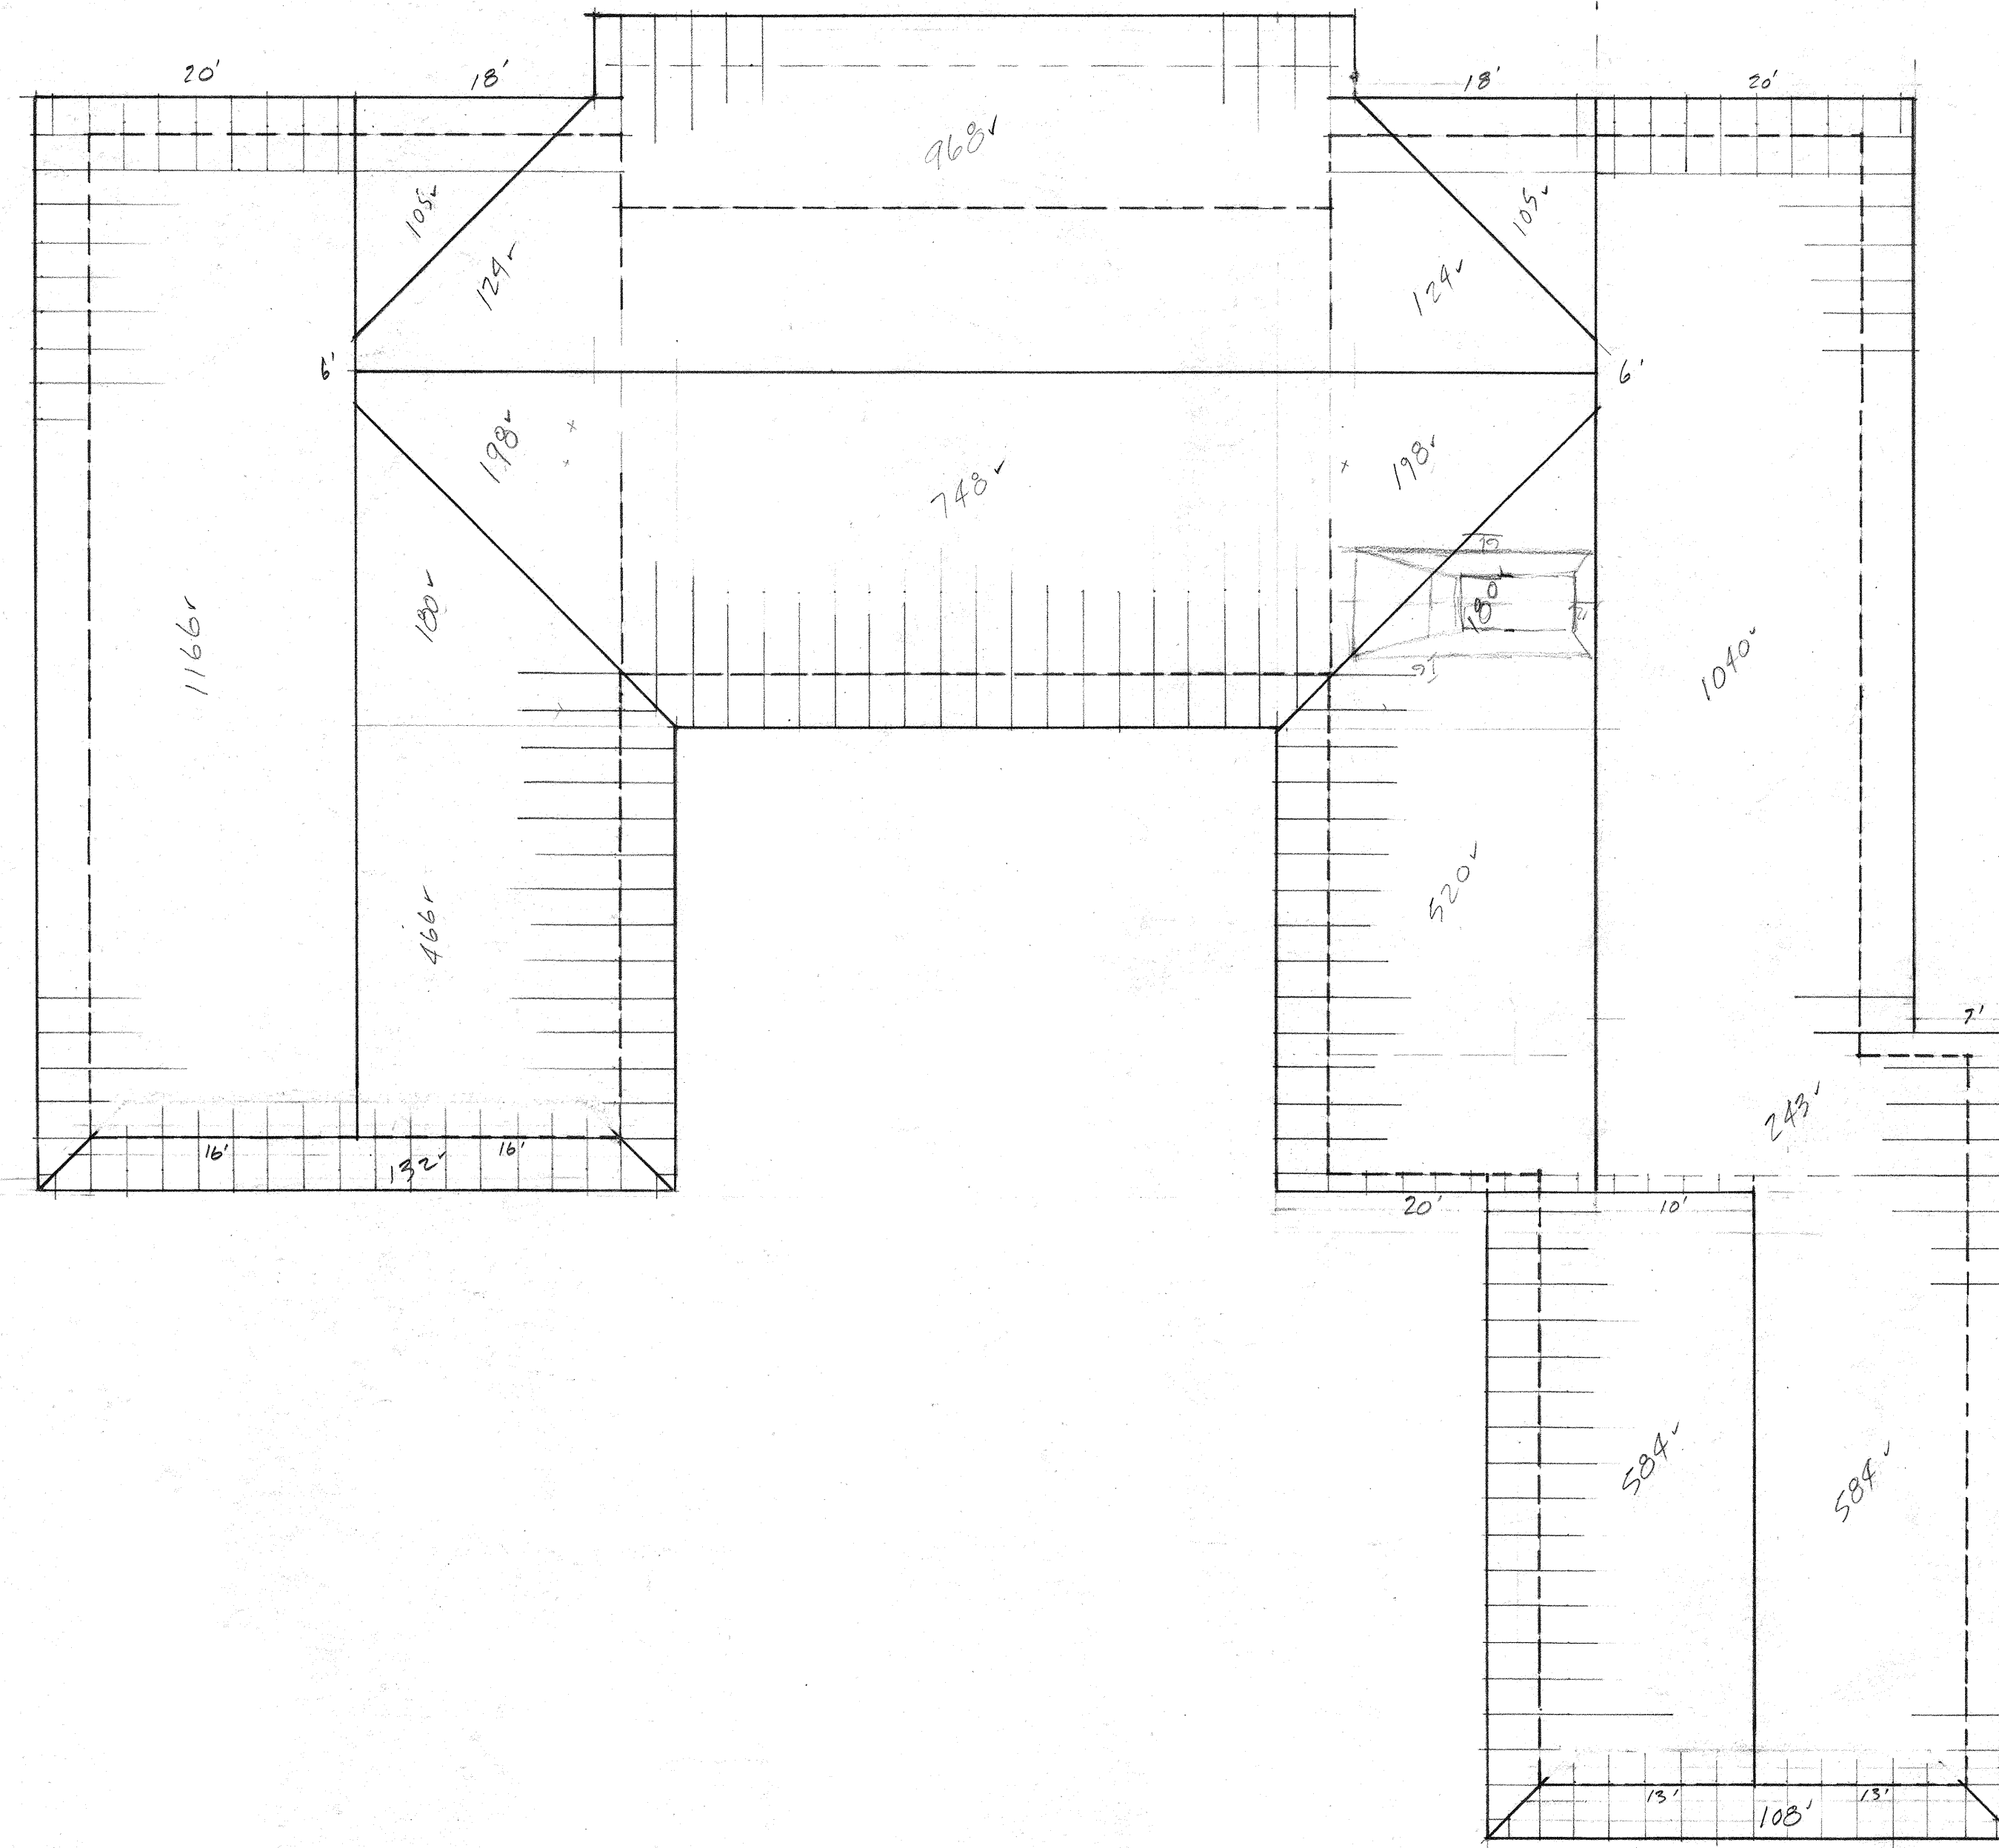

a
b
c
d
f
h
k
m
n
p
s
t
v
w
aa
ac
ad
ef
ah
ak
am
an
ap
as
at
av
aw

ITEM NO.	QTY	PART NO.	MATERIAL	DRAWING NUMBER	DESCRIPTION
Diversified Design Inc. PROFESSIONAL ENGINEERS & DESIGNERS P. O. BOX 1091 EVERETT, WASHINGTON 98201					
PROJECT:					
CUSTOMER:					
DATE	REVISION	APP'D	DRAWN BY	SCALE	DATE
THIS PRINT IS THE PROPERTY OF DIVERSIFIED DESIGN INC. IS CONFIDENTIAL AND IS TO BE USED ONLY IN CONJUNCTION WITH OUR WORK AND IS NOT TO BE COPIED OR REPRODUCED WITHOUT OUR PERMISSION AND TO BE RETURNED UPON REQUEST.			TRACED BY	CHECKED BY	APPROVED
ALL FINISHES DESIGNATED BY A.S.A. STANDARDS IN MICRO-INCHES. ANGULAR TOLERANCE ±1/2°. MACHINED FRACTIONAL DIMENSIONS ±.015". UNLESS OTHERWISE SPECIFIED.			ORDER NO.	CODE	DRWG. NO. REV.
				D-	

4

3

2

1

D

C

B

A


DO NOT SCALE

4

3

2

1

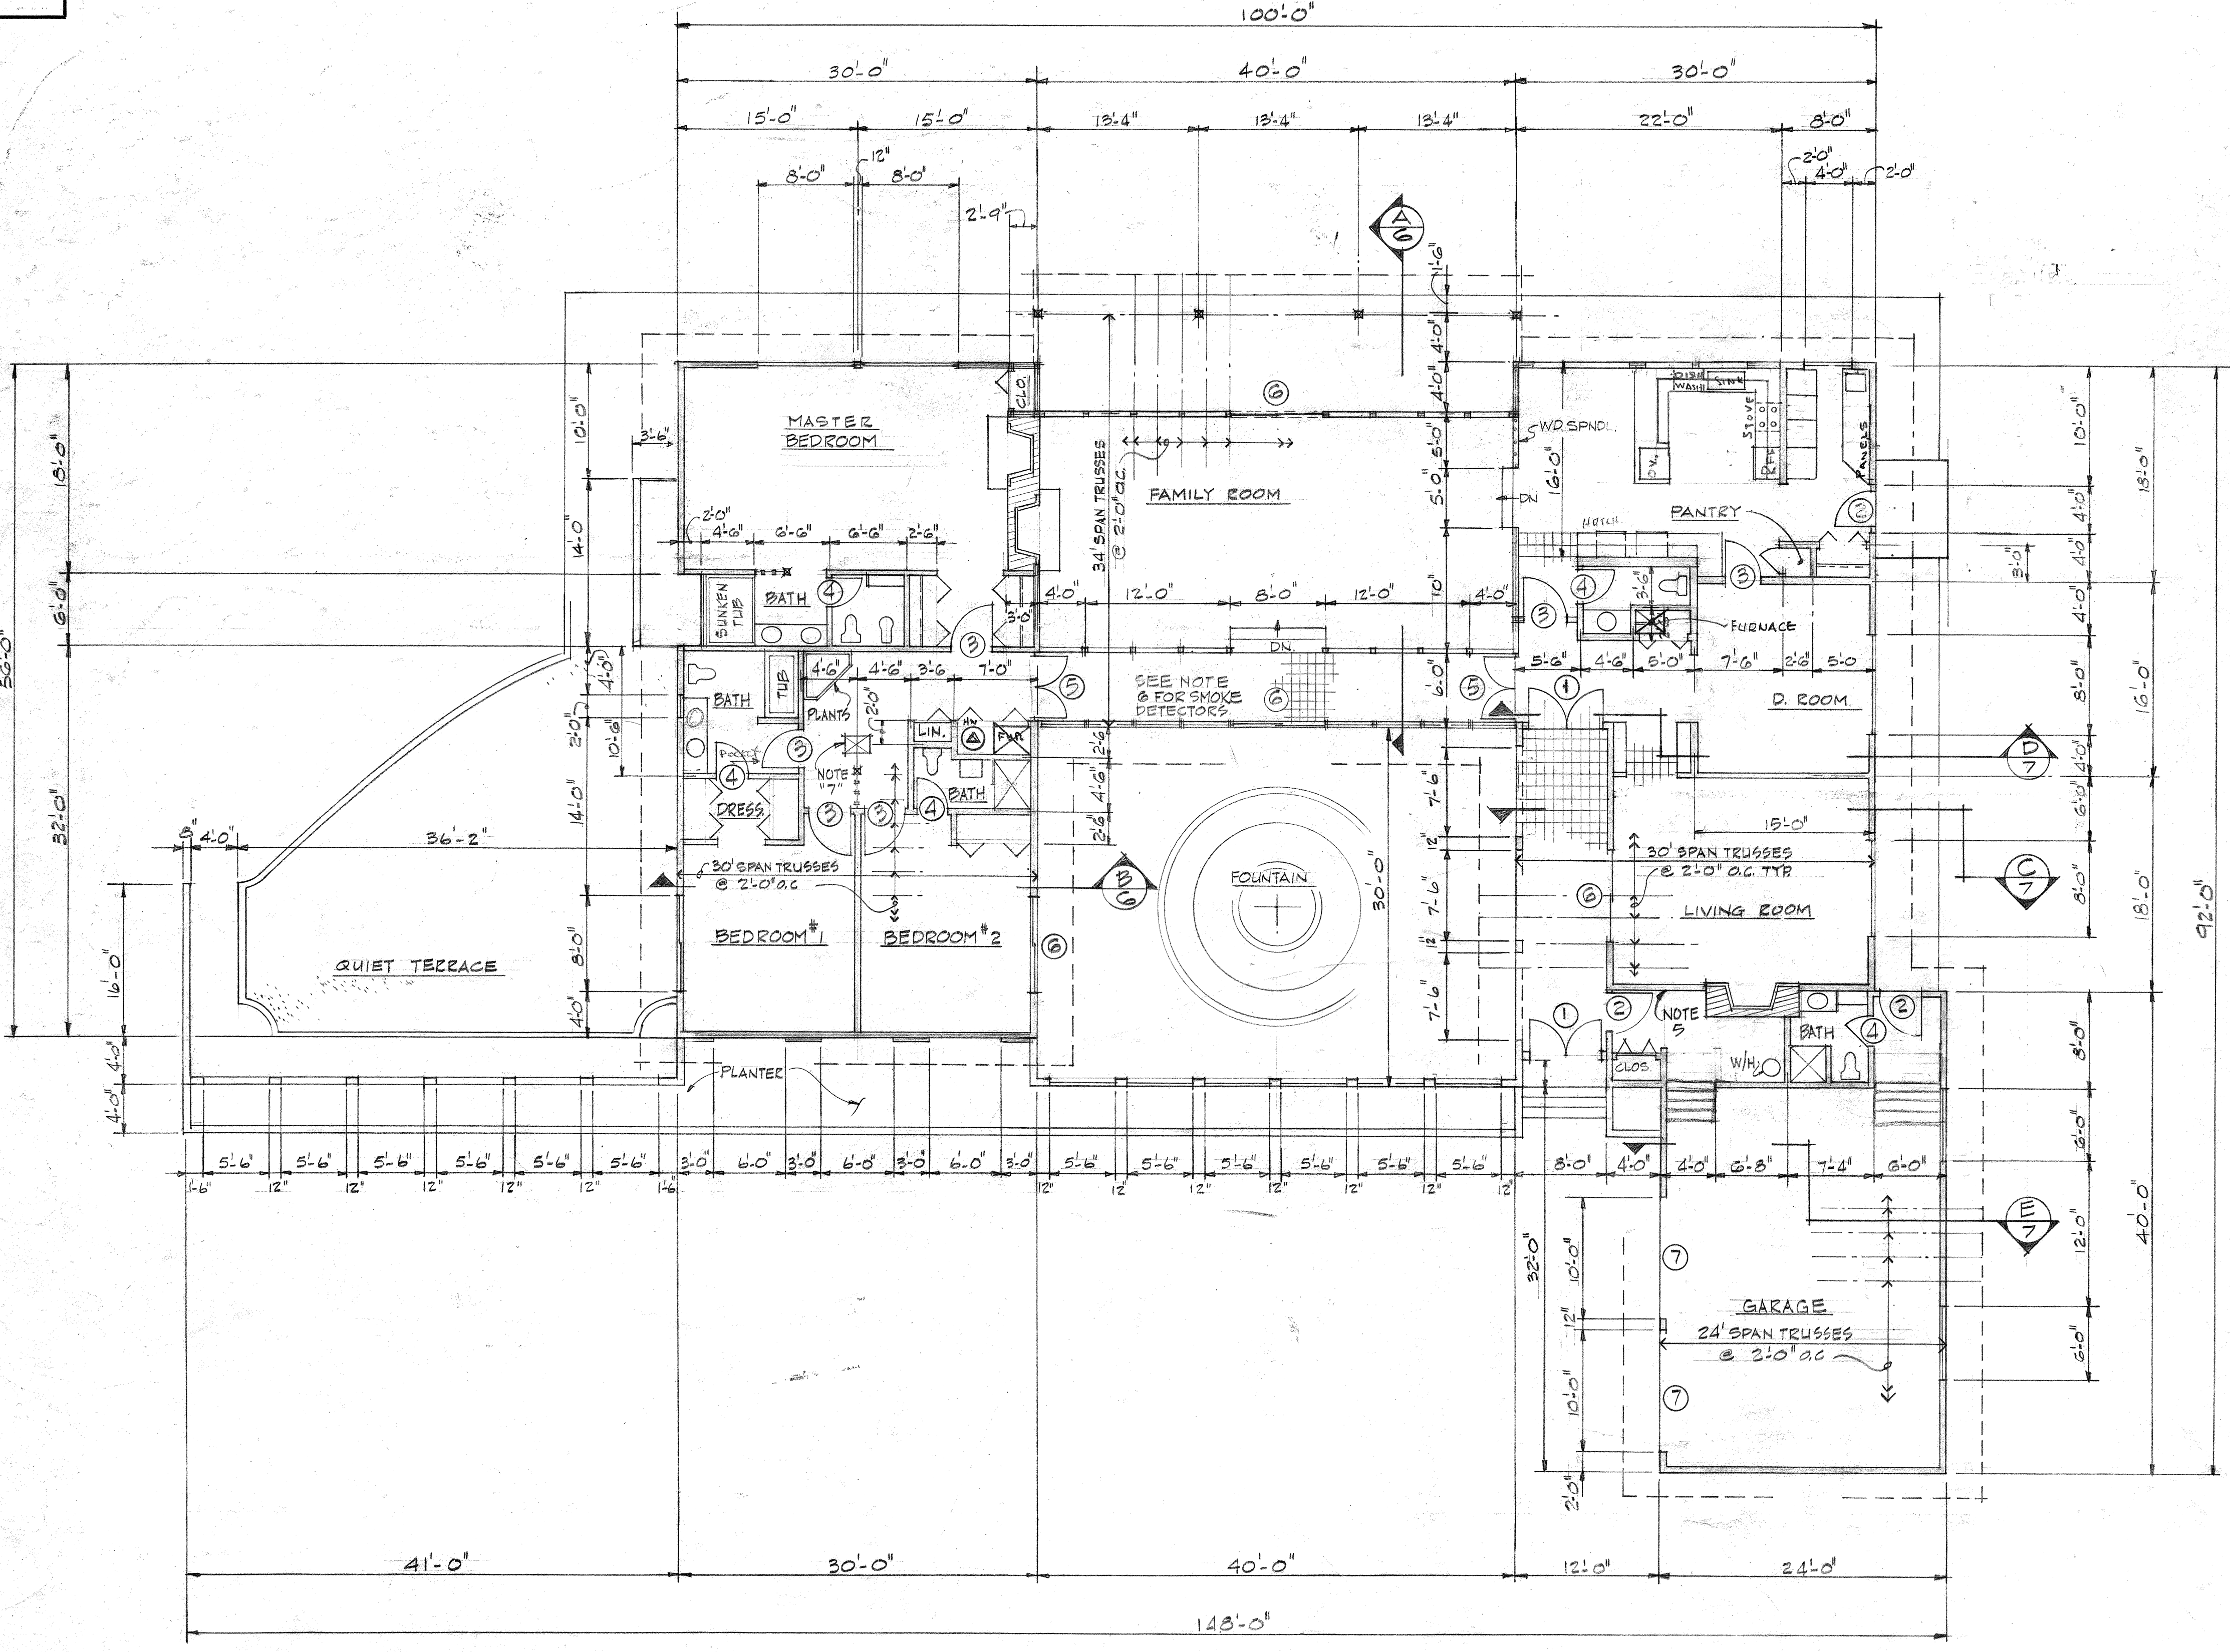

FLOOR PLAN

BILL OF MATERIAL

NO. TO SHIP	SHIP MARK	NO. PCS.	PC. MK.	SECTION	LENGTH		REMARKS
					FT.	IN.	

GENERAL NOTES

- CONFORM TO THE REQUIREMENTS OF THE U.B.C. LATEST EDITION, ALL APPLICABLE LOCAL CODES AND REGULATIONS.
- LIVE LOADS
SNOW 25 P.S.F.
WIND 20 P.S.F.
SEISMIC ZONE III
- SOIL BEARING PRESSURE
2000 P.S.F. MIN.
- VERIFY ALL DIMENSIONS AND ROUGH IN'S.
- 5/8" GYP WALL BD. TYPE "X" ON GARAGE SIDE FOR FIRE SEPARATION
- FIRE & SMOKE DETECTORS SEE ELECTRICAL PLAN
- 22" X 30" MIN ATTIC ACCESS OPENING.

FLOOR PLAN

ITEM NO.	QTY	PART NO.	MATERIAL	DRAWING NUMBER	DESCRIPTION
Diversified Design Inc. PROFESSIONAL ENGINEERS & DESIGNERS P. O. BOX 1081 EVERETT, WASHINGTON 98201					
PROJECT:					
CUSTOMER:					
DATE	REVISION	APP'D	DRAWN BY <i>BRJ/M</i> SCALE 1/8" = 1'-0" DATE APRIL 1, 75		
TRACED BY			CHECKED BY	APPROVED	
ORDER NO.	CODE	DRWG. NO.	REV.	R.D. D-3 OF 11	

4

3

2

1

4

3

2

1


DO NOT SCALE

BILL OF MATERIAL

NO. TO SHIP	SHIP MARK	NO. PCS.	PC. MK.	SECTION	LENGTH		REMARKS
					FT.	IN.	

GENERAL CONCRETE NOTES

- BOTTOMS OF ALL FOOTINGS TO REST ON UNDISTURBED SOIL OR APPROVED COMPACTED FILL.
- CONC. MIN. 28 DAY STRENGTH TO EQUAL 2000 P.S.I. USE 5 SACK MIX WITH 4" MAX. SLUMP
- VIBRATE CONC. WALLS HIGHER THAN 2'- AT PLACEMENT OF CONC.
- REINF WALLS & FOOTINGS PER CONC. SECTIONS AND DETAILS
- VERIFY ALL DIMENSIONS.
- CONTACT OWNER WHEN IN QUESTION & PRIOR TO POURING CONC.
- LOCATE & INSTALL ALL UNDER GROUND WIRE CONDUIT & PIPING PRIOR TO POURING SLAB

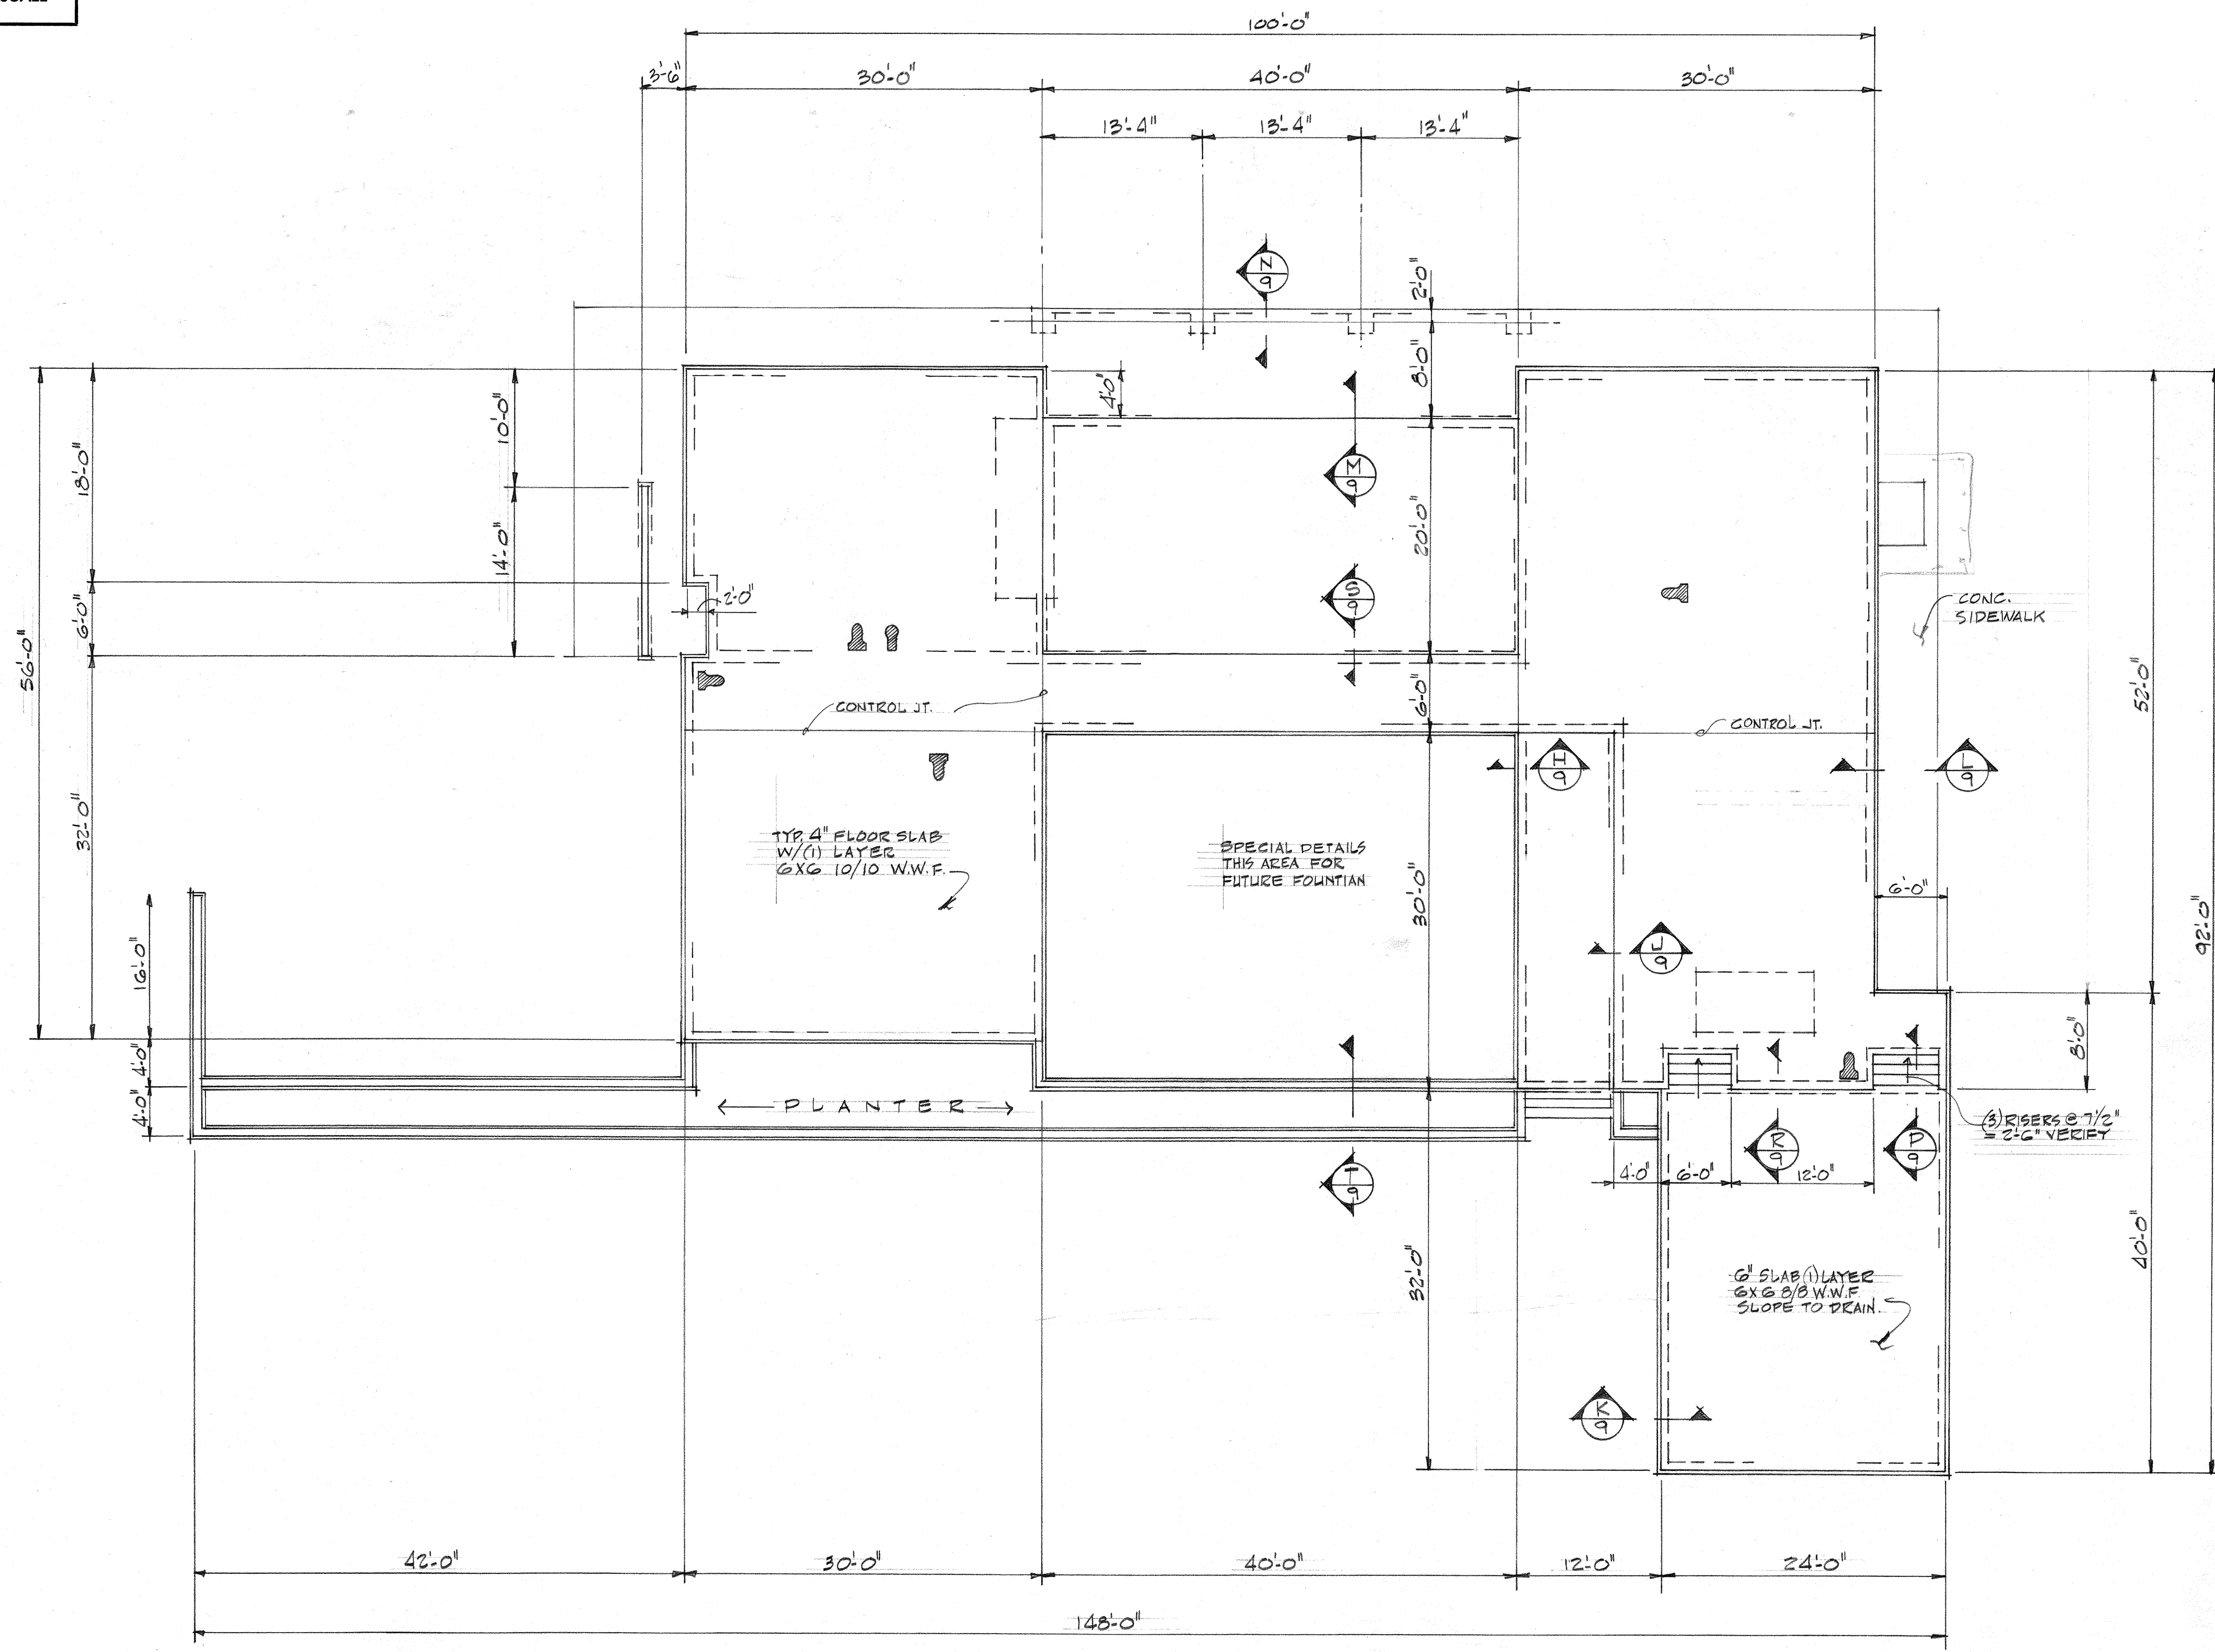

FOUNDATION PLAN

FOUNDATION PLAN

ITEM NO.	QTY	PART NO.	MATERIAL	DRAWING NUMBER	DESCRIPTION
<p align="center">Diversified Design Inc. PROFESSIONAL ENGINEERS & DESIGNERS P. O. BOX 1081 EVERETT, WASHINGTON 98201</p>					PROJECT:
					CUSTOMER:
DATE	REVISION	APP'D	DRAWN BY	SCALE	DATE
			MILL.	1/8" = 1'-0"	APR 10, 75
<small>THIS PRINT IS THE PROPERTY OF DIVERSIFIED DESIGN INC. IS CONFIDENTIAL AND IS NOT TO BE COPIED OR REPRODUCED WITHOUT OUR PERMISSION AND TO BE RETURNED UPON REQUEST.</small>					TRACED BY
<small>ALL FINISHES DESIGNATED BY A.S.A. STANDARDS IN MICRO-INCHES. ANGULAR TOLERANCE 3/32". MACHINED FRACTIONAL DIMENSIONS ±.015". UNLESS OTHERWISE SPECIFIED.</small>					CHECKED BY
ORDER NO.	CODE	DRWG. NO.	REV.		
	R.D.	D-3 OF 11-A			

4

3

2

1

a
b
c
d
e
f
g
h
i
j
k
l
m
n
o
p
q
r
s
t
u
v
w
x
y
z

4

3

2


1

DO NOT SCALE

BILL OF MATERIAL

NO. TO SHIP	SHIP MARK	NO. PCS.	PC. MK.	SECTION	LENGTH		REMARKS
					FT.	IN.	

a
b
c
d
e
f
g
h
i
j
k
l
m
n
o
p
q
r
s
t
u
v
w
x
y
z
aa
ab
ac
ad
ae
af
ag
ah
ai
aj
ak
al
am
an
ao
ap
aq
ar
as
at
au
av
aw

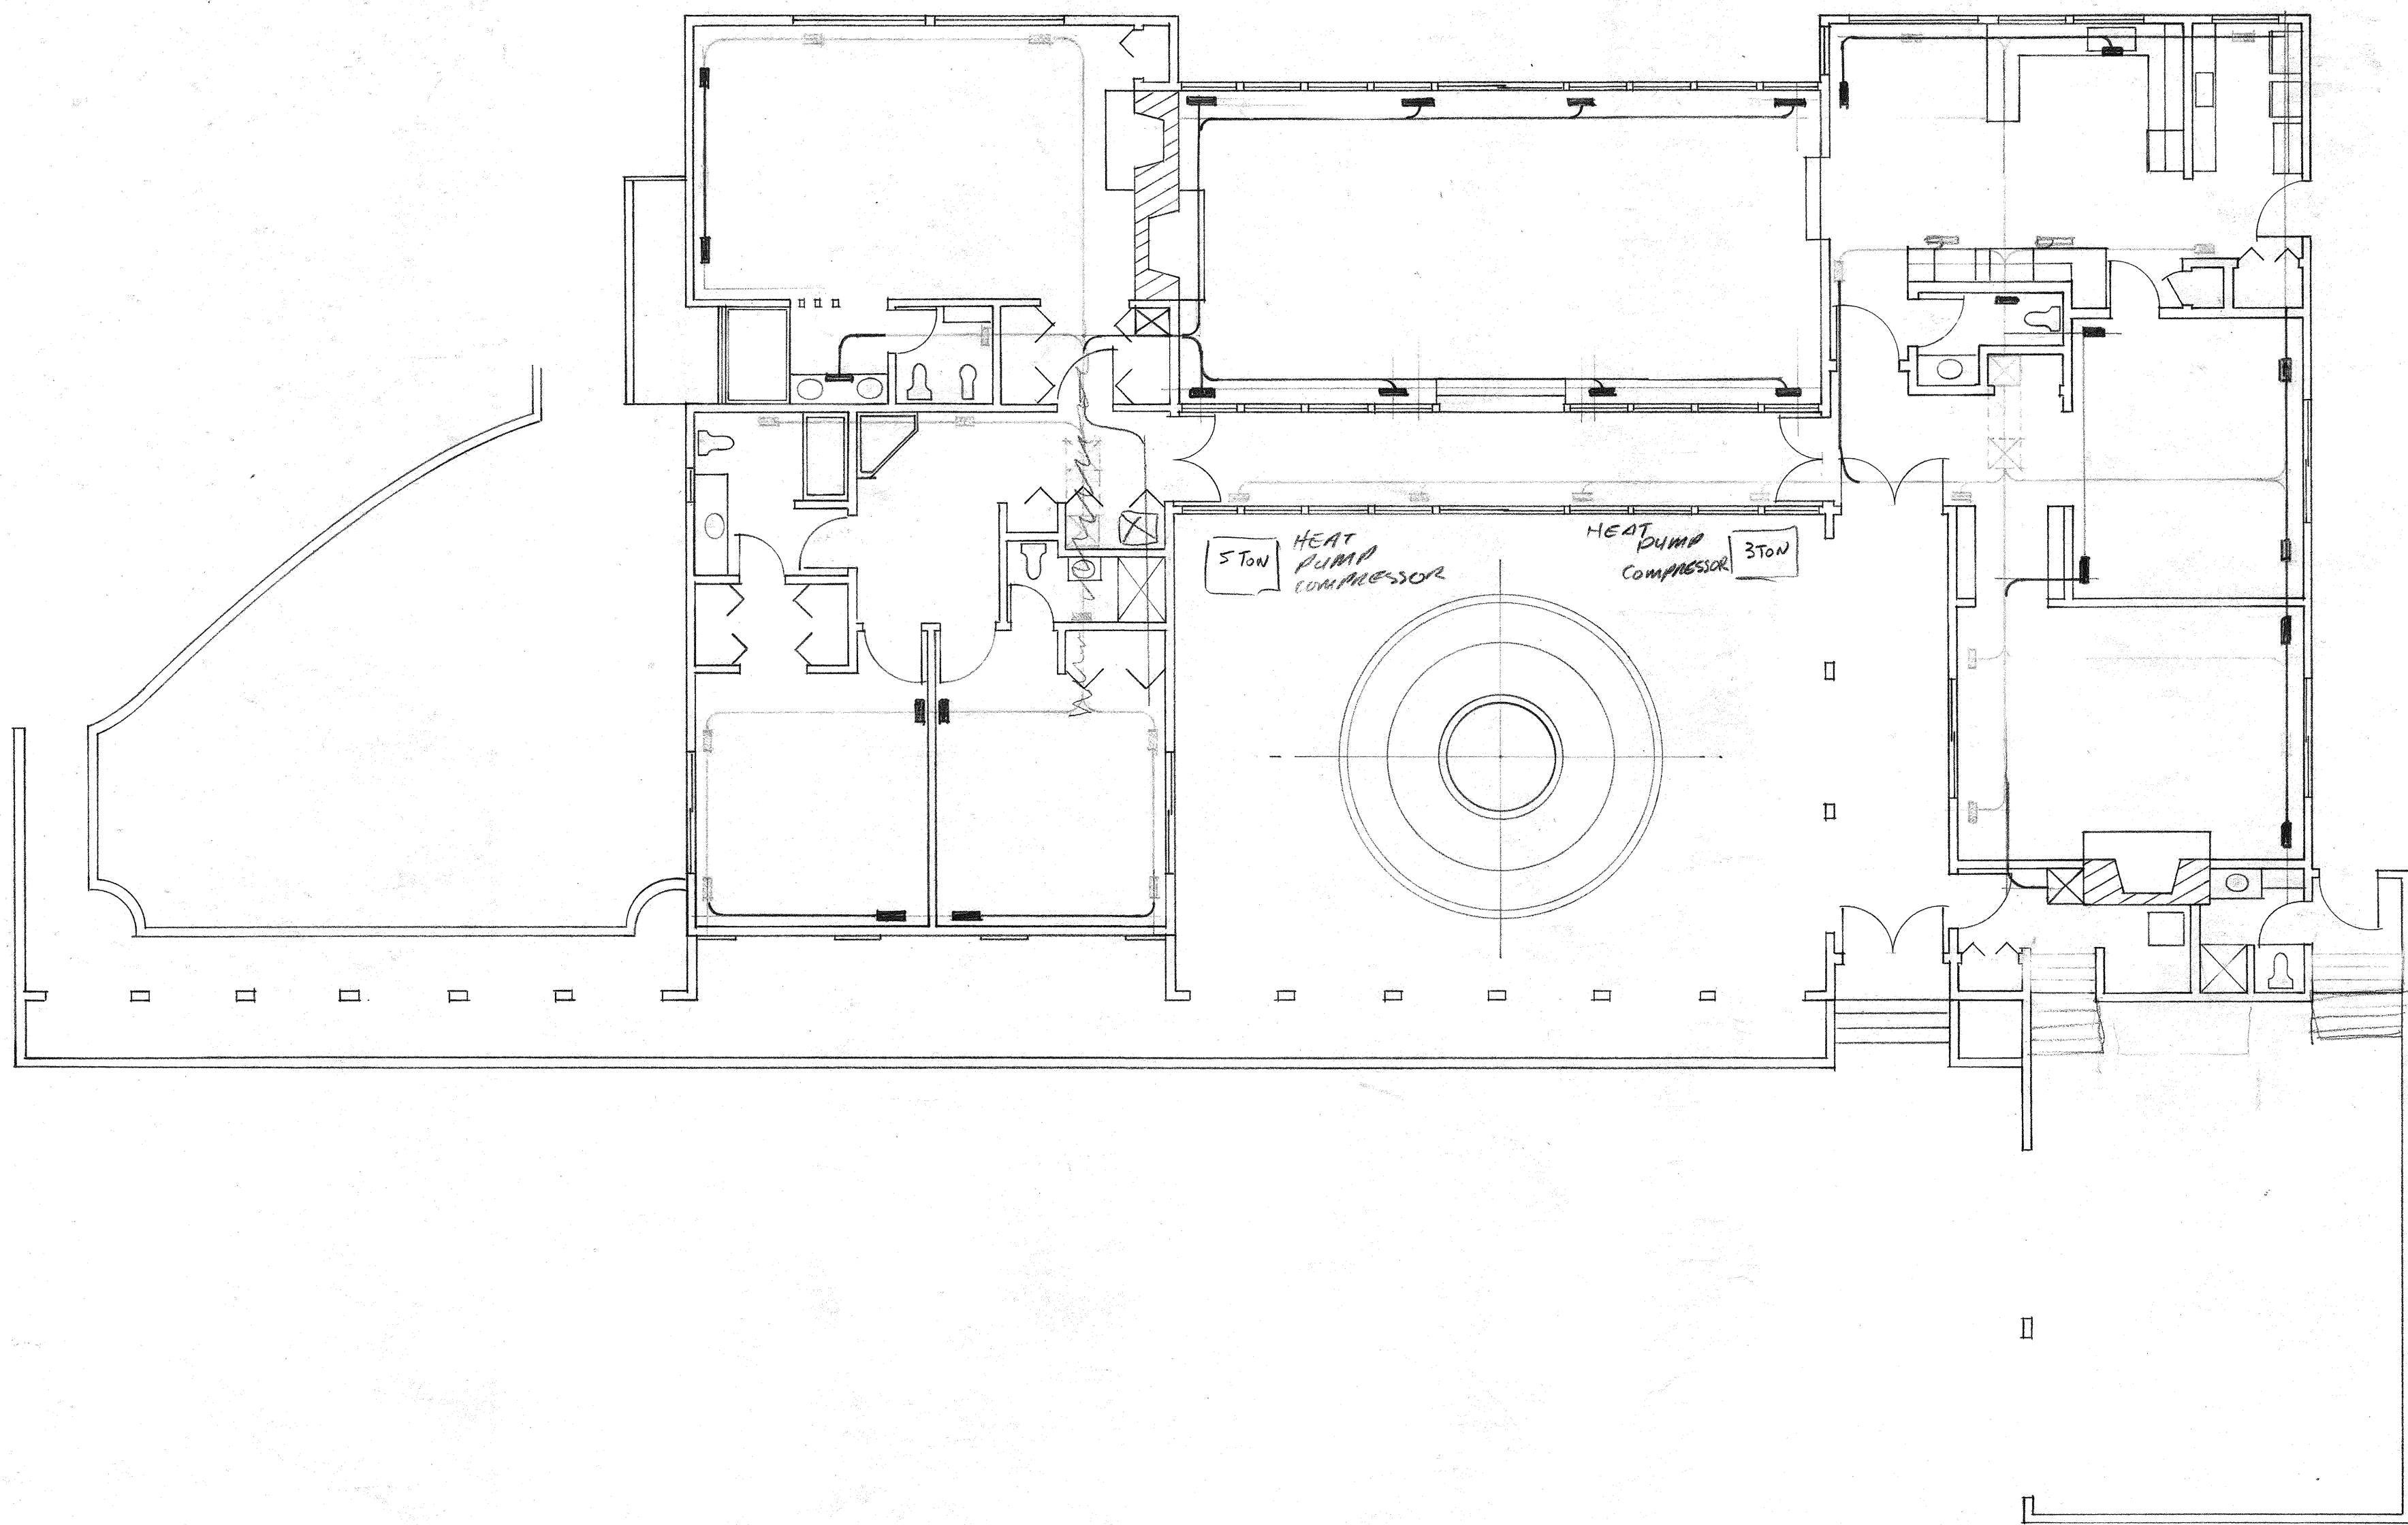

HEATING PLAN

HEATING PLAN

ITEM NO.	QTY	PART NO.	MATERIAL	DRAWING NUMBER	DESCRIPTION
					Diversified Design Inc. PROFESSIONAL ENGINEERS & DESIGNERS P. O. BOX 1081 EVERETT, WASHINGTON 98201
					PROJECT: <u>CHINA BLDG</u> <u>SYSTEMS FOR PLANS</u>
					CUSTOMER
DATE	REVISION	APP'D			
<small>THIS PRINT IS THE PROPERTY OF DIVERSIFIED DESIGN INC. IS CONFIDENTIAL AND IS TO BE USED ONLY IN CONJUNCTION WITH OUR WORK AND IS NOT TO BE COPIED OR REPRODUCED WITHOUT OUR PERMISSION AND TO BE RETURNED UPON REQUEST. ALL FINISHES DESIGNATED BY A.S.A. STANDARDS IN MICRO-INCHES. ANGULAR TOLERANCE 1/2°. MACHINED FRACTIONAL DIMENSIONS ±.015", UNLESS OTHERWISE SPECIFIED.</small>					<small>DRAWN BY</small> SUE <small>SCALE</small> 1/8"=1'-0" <small>DATE</small> 4-16-75 <small>TRACED BY</small> <small>CHECKED BY</small> <small>APPROVED</small> <small>ORDER NO.</small> <small>CODE</small> <small>DRWG. NO.</small> <small>REV.</small> RD D-110E11

4

3

2

1

D

C

B

A

